


MUGANYA JP School

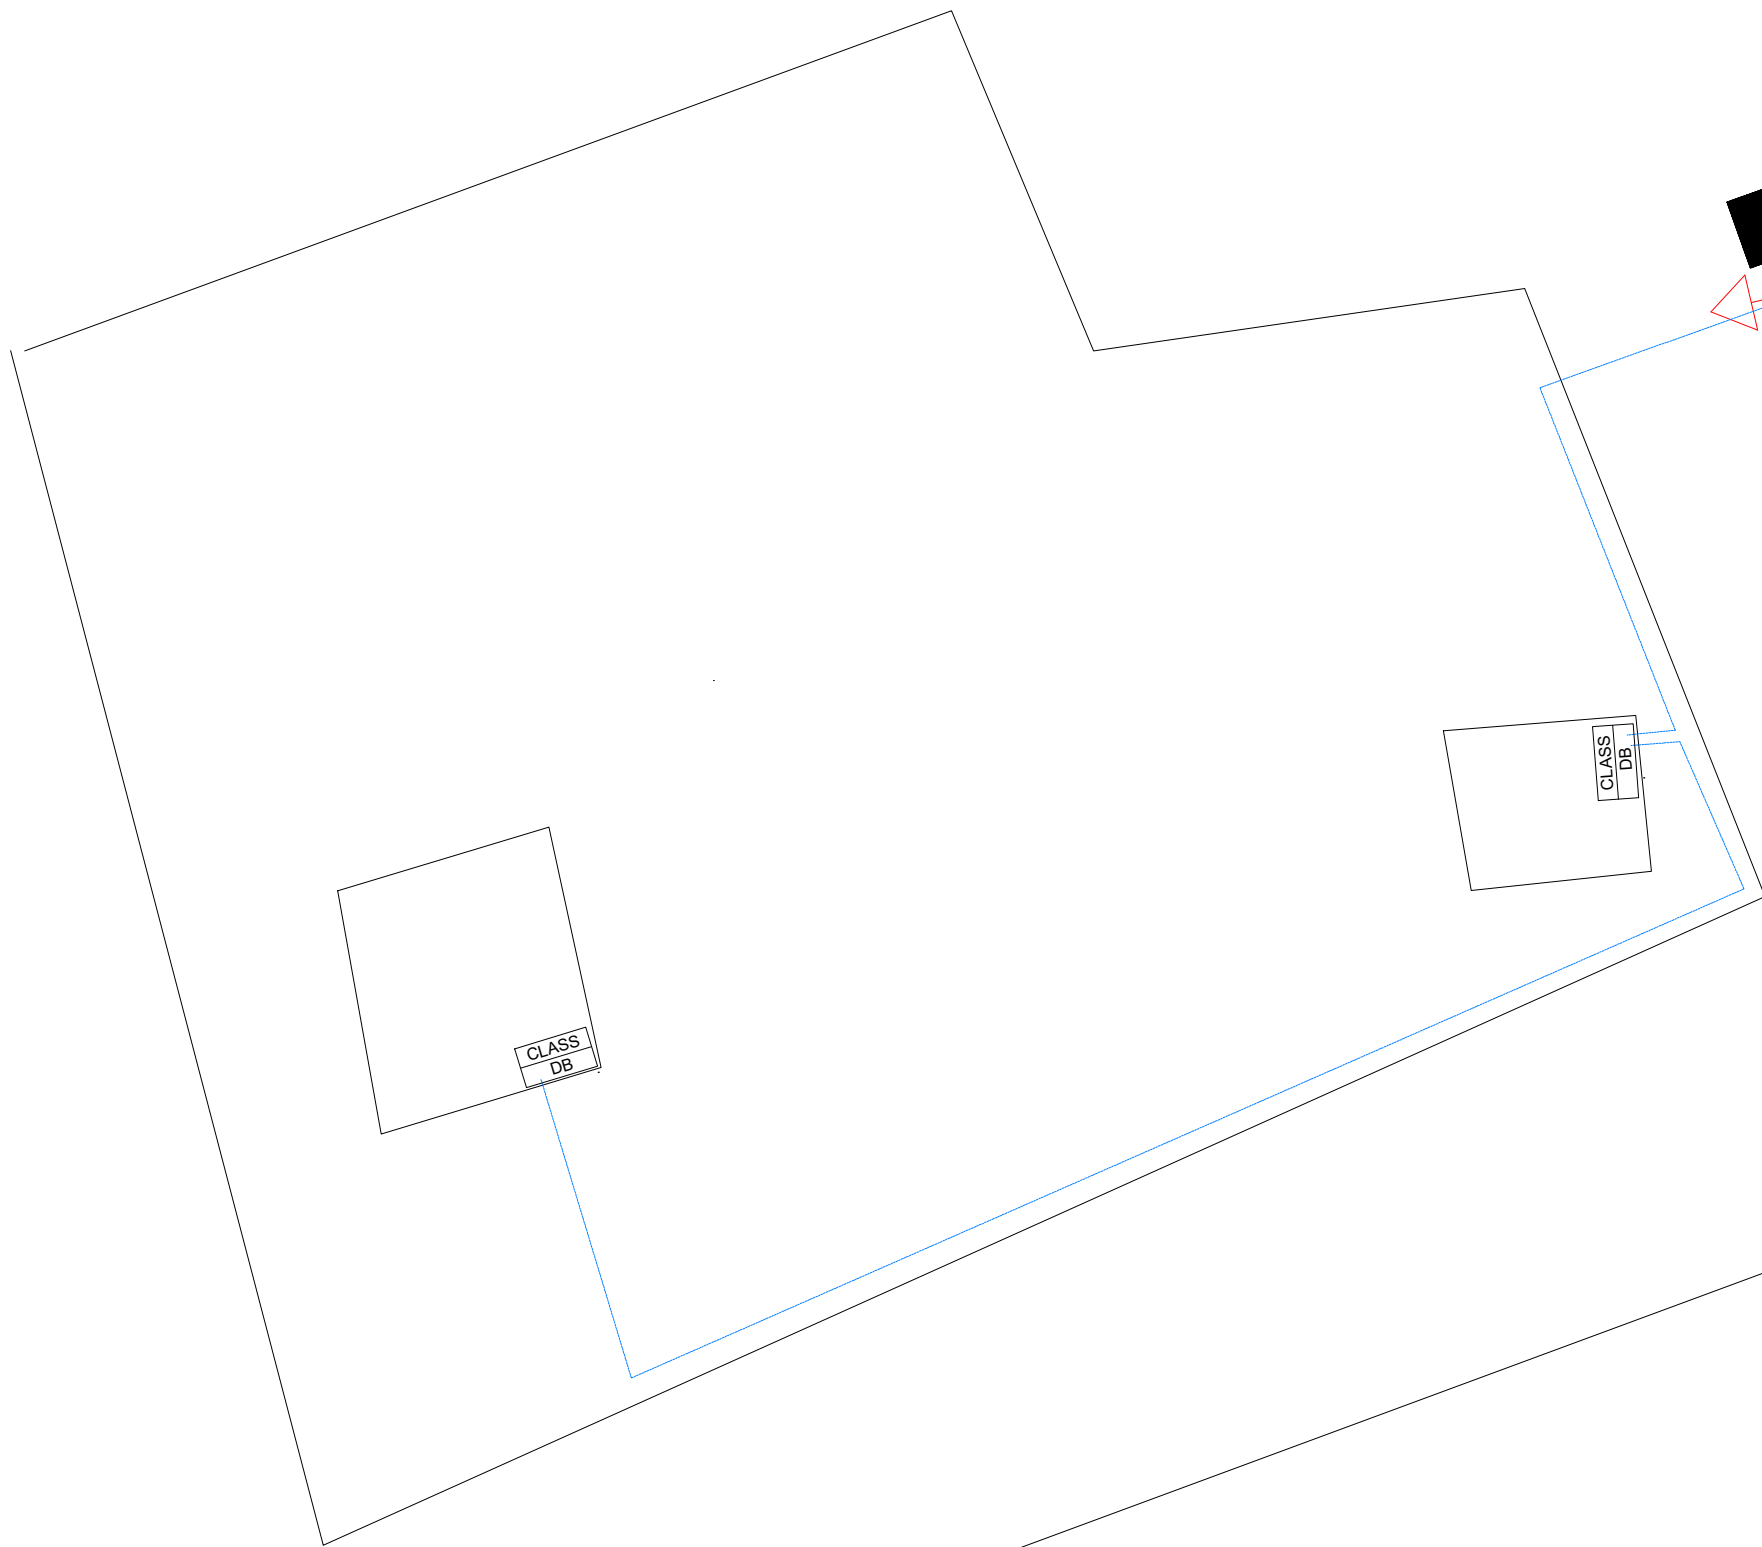

45m

45m

- NOTES:
1. CONTRACTOR TO CHECK ALL DIMENSIONS ON SITE & ON DRAWINGS.
 2. ANY DISCREPANCIES MUST BE REPORTED TO ENGINEER. FIGURED
 3. DIMENSIONS ARE TO BE TAKEN IN PREFERENCE TO THOSE SCALED.
 4. ALL ITEMS TO BE CONFIRMED AND APPROVED BY ENGINEER BEFORE SUPPLY & INSTALLATION.
 5. THIS DRAWING IS PROPERTY OF AFRI CONSULTING ENGINEERS COPYRIGHT IS RESERVED BY THEM AND THE DRAWING IS ISSUED ON THE CONDITION THAT IT IS NOT COPIED, REPRODUCED, RETAINED OR DISCLOSED TO ANY UNAUTHORIZED PERSON, EITHER WHOLLY OR IN PART WITHOUT THE WRITTEN CONSENT OF AFRI CONSULTING ENGINEERS.
 5. ALL WIRINGS & INSTALLATIONS TO COMPLY WITH SANS10142-1 STANDARDS FOR WIRING OF BUILDING PREMISES.

REVISION			
DATE	NO.	REMARKS	BY

CLIENT:

MINISTRY OF MINES AND ENERGY
6 AVIATION ROAD
PRIVATE BAG 13297
WINDHOEK, NAMIBIA
TEL.: +264-61-284 8111
FAX: +264-61-238643/ 220386
EMAIL: info@mme.gov.na



USER CLIENT:

NORED ELECTRICITY (PTY) LTD
PO Box 389
ONDANGWA
NAMIBIA
TEL.: +264 65 281850
FAX: +264 65 241603



ELECTRICAL ENGINEER:

AFRI CONSULTING ENGINEERS
P.O. BOX 55100 , ROCKY CREST
WINDHOEK, NAMIBIA
TEL.: +264-61 300 554
CELL: +264 81 299 3333



ELECTRICAL LEGEND

ITEM	DESCRIPTION
	LV Pole
	MV Pole
	Kicker Pole
	Earth
	LV Stay/Strut
	MV Stay/Strut
	Drop-out Fuse / Load Break Fuses
	Street Lights
	Meter Board
	Distribution Board
	Kiosk
	Ring Main Unit
	Mini-Sub
	Robots/Traffic lights
	Transformer
	Generator
	Un-Interrupted Power Supply
	Recloser
	House
	Pole Box
	400V Underground cable
	Street Lights Underground lines
	Service Connections
	400V ABC line
	11KV Overhead line
	22KV Overhead line
	33KV Overhead line

FOR TENDER
PURPOSES ONLY

PROJECT TITLE:

2023 MME RURAL
ELECTRIFICATION - KAVANGO
REGION

DRAWINGS:

MUGANYA SITE LAYOUT

DRAWN:

H.T.K

CHECKED:

J.T.N

SCALE:

As shown when
printed on A3

DATE:

DEC 2023

DRAWING NUMBER:

AFRI_2022_034_EE_11

REVISION:

-